


Top View

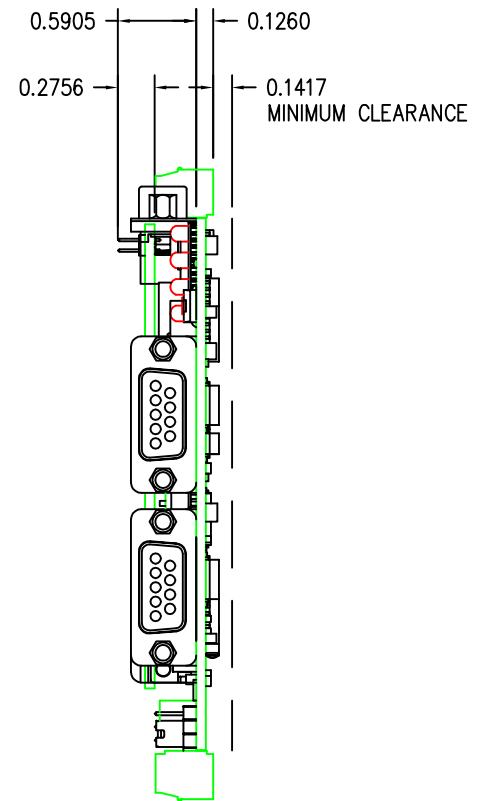

Side View

Drawn By : S. Markusoff Date : 21:07:05

Approved By : B.P. Mulligan Date : 21:07:05

Revision : D Size : 8.5" x 11" Scale : N.T.S.

Drawing Number : 104-00010

Drawing Title : IDI 1320 Rev D – MECHANICAL LAYOUT

Client : INTELLIGENT DEVICES, INC



Intelligent Devices Inc.
3449-A, Lawrenceville, Suwanee Rd, Suwanee, GA 30094